



ELECTRICAL NOTES:

1. CONFIRM LOCATION OF TV, PHONE, ETHERNET AND SOFFIT OUTLETS WITH OWNER.
2. CONFIRM LOCATION OF ALL EXT. FLOOD LIGHTS SECURITY DEVICES AND MOTION SENSORS.
3. PROVIDE LIGHT WITH SWITCH IN ALL ATTIC CRAWL SPACES.
4. 120 VOLT SMOKE DETECTOR REQUIRED ON EACH FLOOR LEVEL. ALL INTERCONNECTED AND LOCATED AS NOTED ON PLANS.
5. ALL RECESSED CAN LIGHTS TO BE IC-RATED FIXTURES.

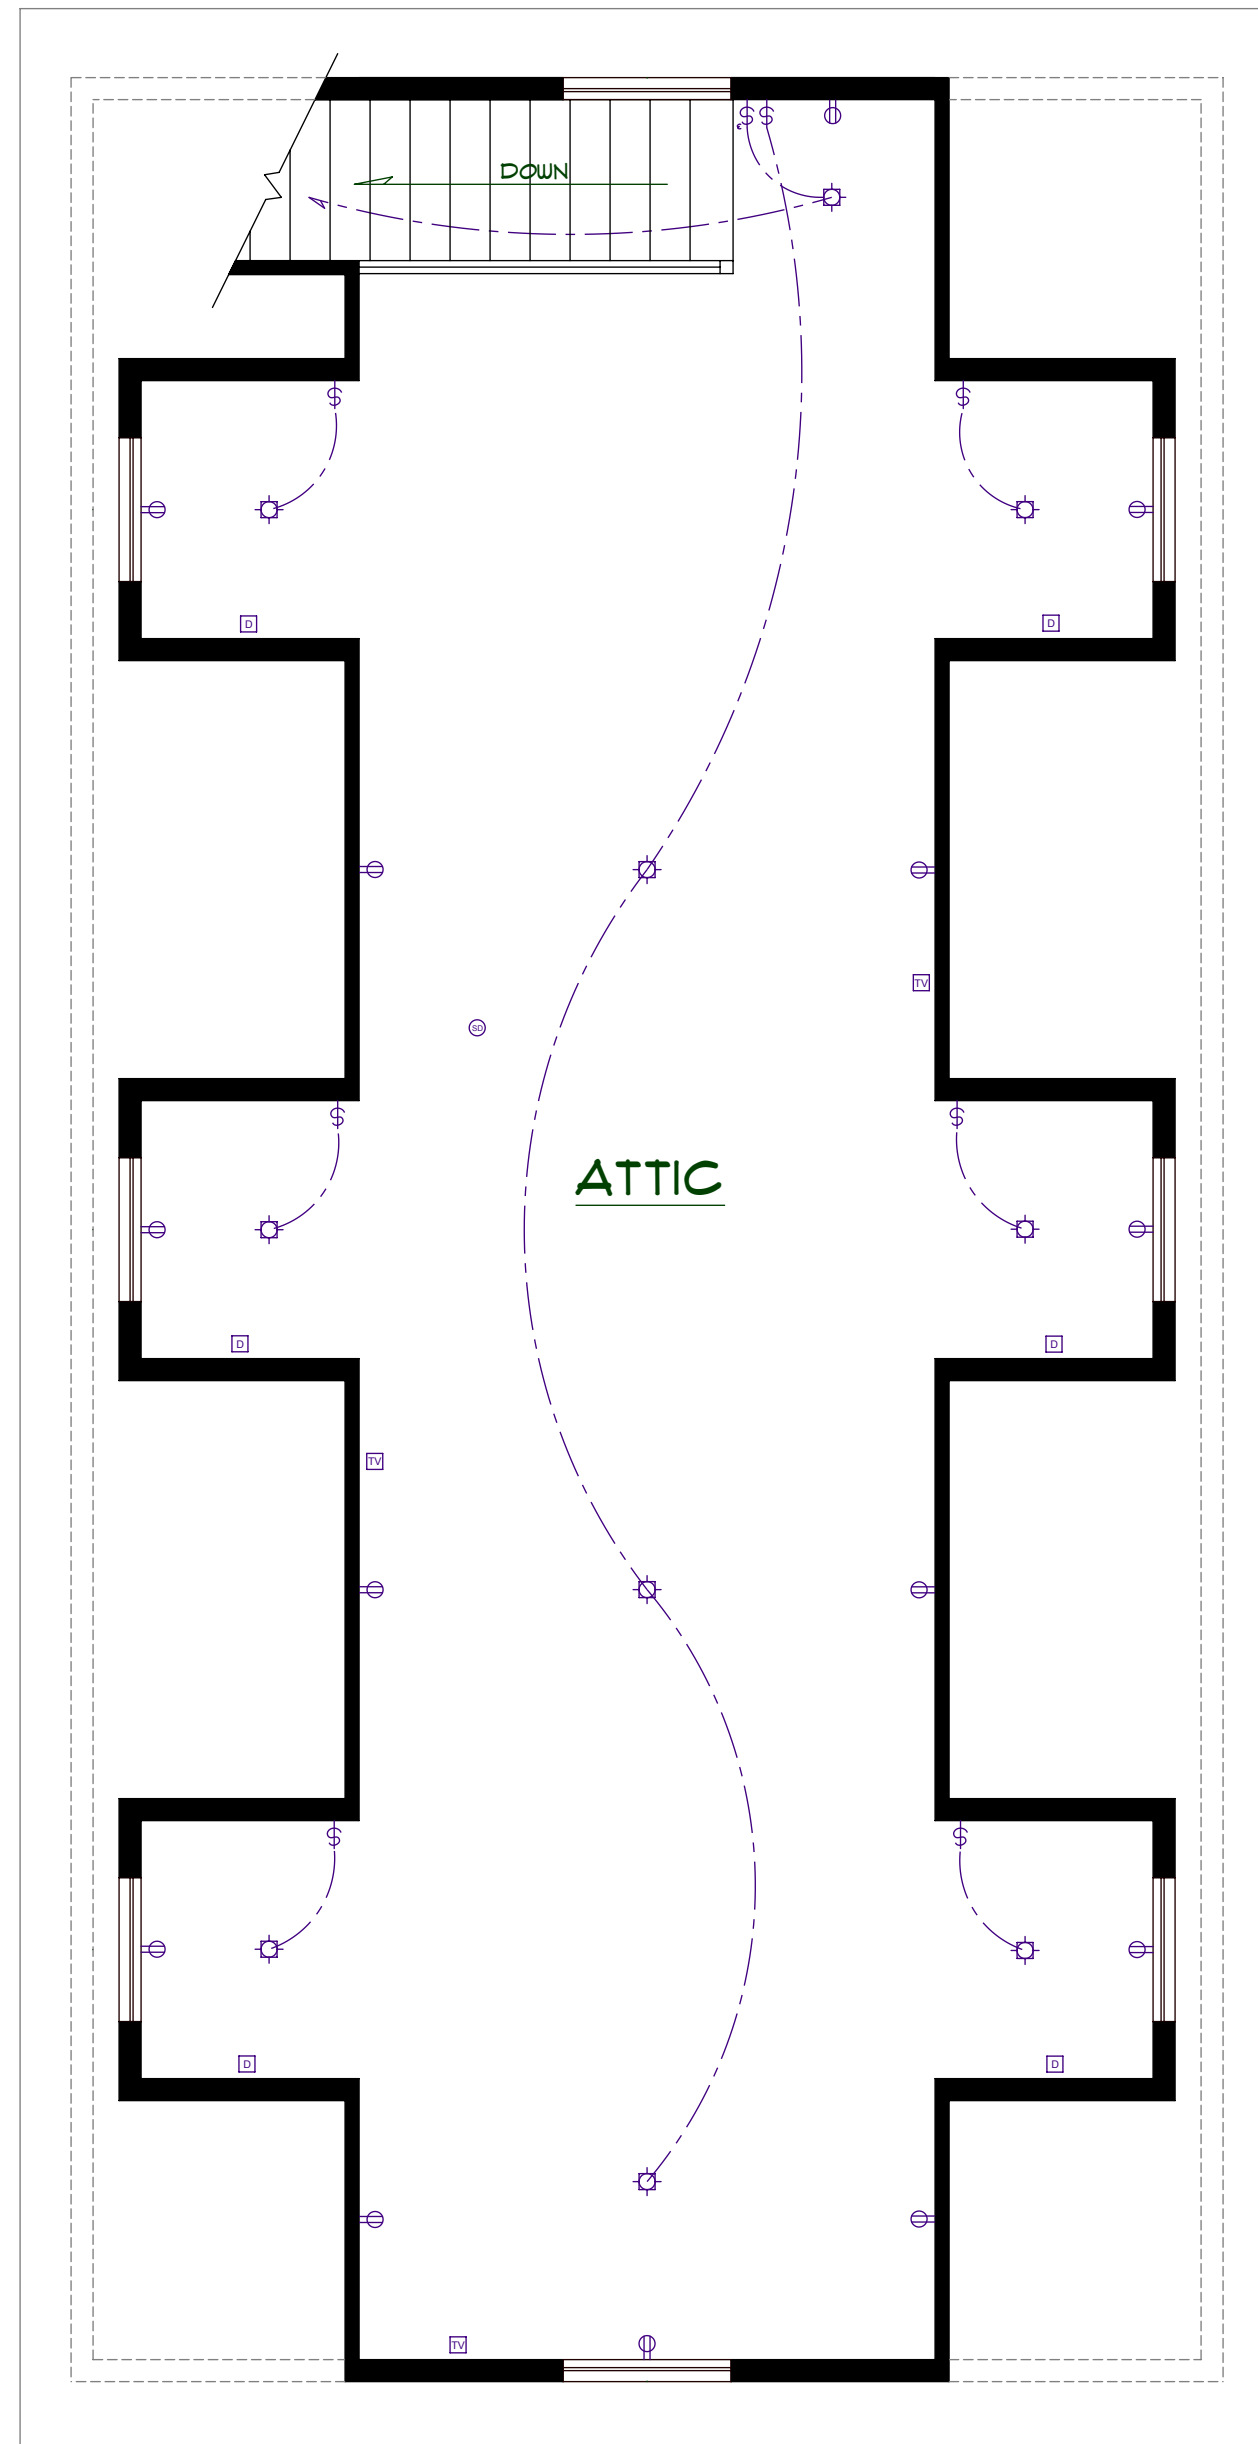


ATTIC ELECT. PLAN

SCALE: 1/4"=1'-0"

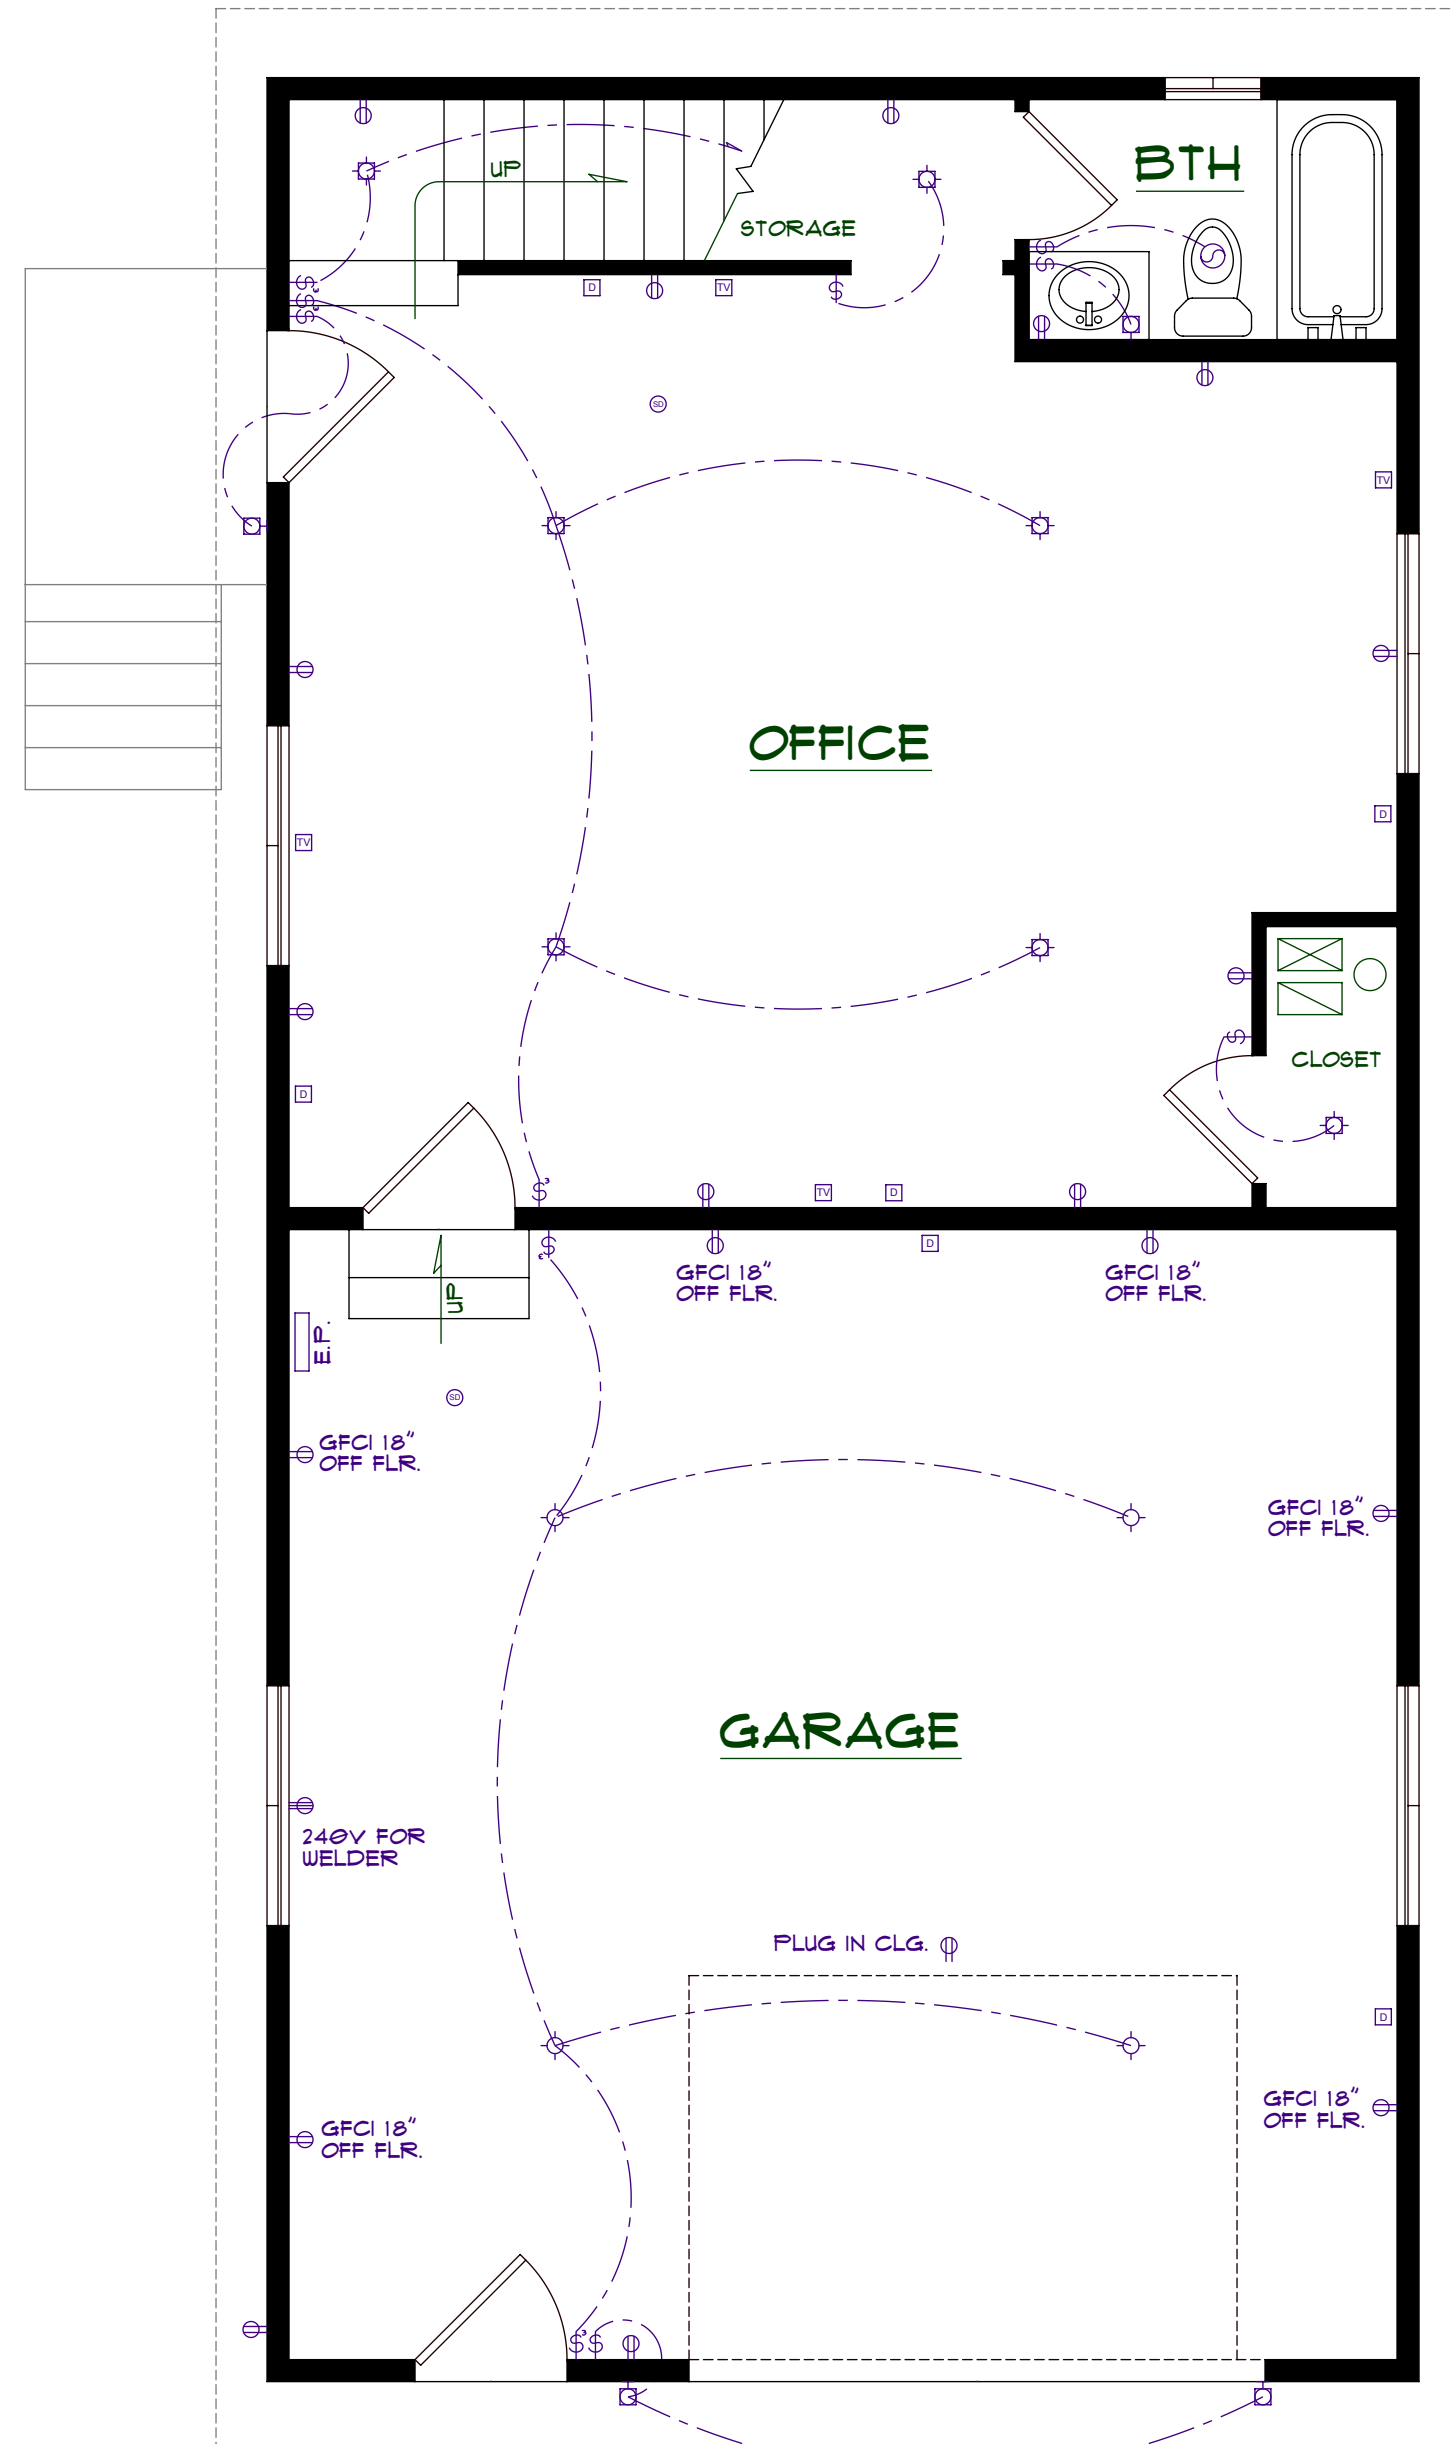

MAIN FLOOR ELECT. PLAN

SCALE: 1/4"=1'-0"

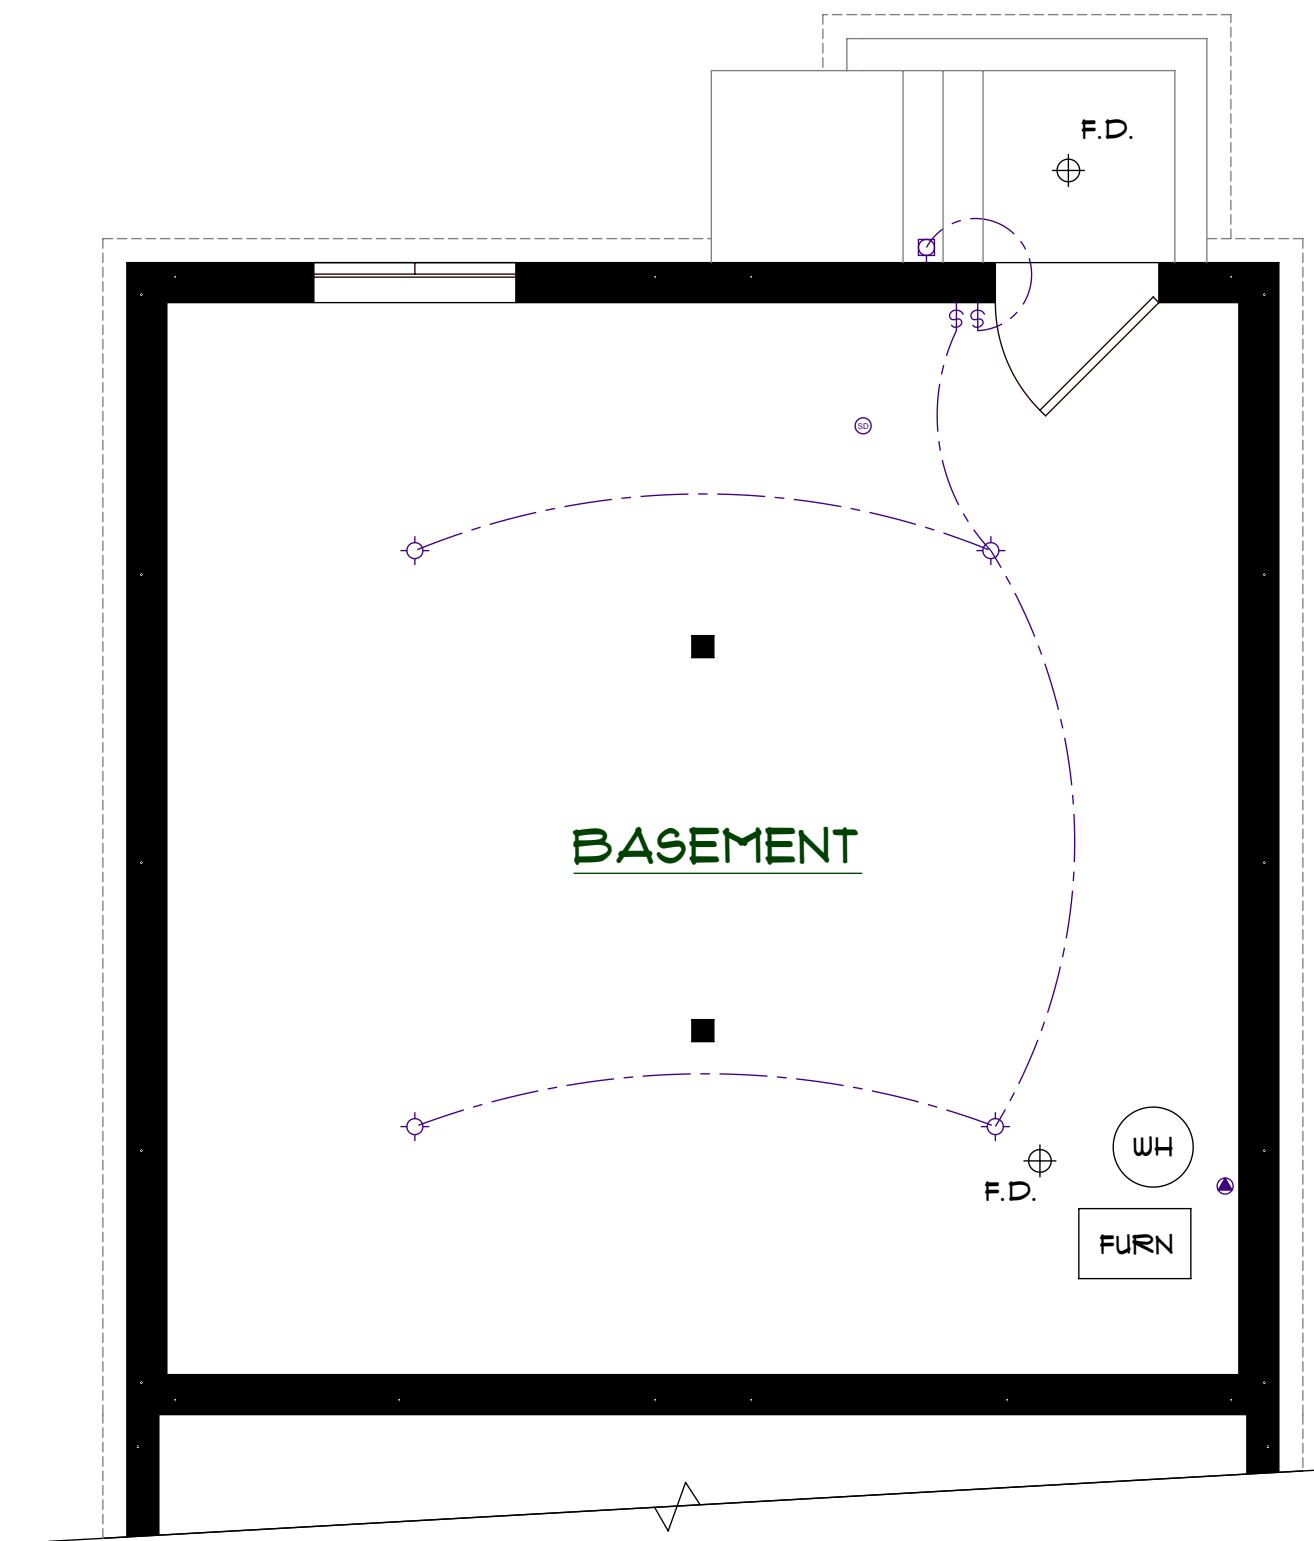

BASEMENT ELECT. PLAN

SCALE: 1/4"=1'-0"

ELECT. SYMBOL LEGEND

- ⊕ SWITCH
- ⊕ 3-WAY SWITCH
- ⊕ 120 VOLT OUTLET
- ⊕ DEDICATED CIRCUIT
- ⊕ 240 VOLT CIRCUIT
- ⊕ STANDARD LIGHT FIXT.
- ⊕ RECESSED CAN LIGHT
- ⊕ WALL LIGHT FIXT.
- ⊕ SMOKE DETECTOR
- ⊕ EXHAUST FAN
- ⊕ DATA/PHONE JACK
- ⊕ TELEVISION JACK



MEDEEK DESIGN
INC.
403 SOUTH 10TH AVENUE SUITE 100
PHOENIX, AZ 85001
DESIGN@MEDEEK.COM

PLAN NO. **SHOP4824-A6DB**
SCALE: 1/8"=1'-0"
REVISION: A.1

DESIGNED BY: **NPW**
DATE: **3/17/2012**

SHEET CONTENTS:
ELECTRICAL PLANS

REVISION HISTORY:

CUSTOMER: _____
LOCATION: _____
SHEET